



PANDA EXPRESS, INC.
1683 Walnut Grove Ave.
Rosemead, California
91770
Telephone: 626.799.9898
Facsimile: 626.372.8288

All ideas, designs, arrangement and plans indicated or represented by this drawing are the property of Panda Express Inc. and were created for use on this specific project. None of these ideas, designs, arrangements or plans may be used by or disclosed to any person, firm, or corporation without the written permission of Panda Express Inc.

REVISIONS:		
ISSUE DATE:		
	PEER REVIEW	01-27-2020
	PR RESPONSE 1	02-21-2020
	BUILDING PERMIT	03-11-2020

DRAWN BY: G. COLLINS

PANDA PROJECT #: D7446


ARCH PROJECT #: JCDT19-0314




PANDA EXPRESS
GREENBRIAR TOWN CENTER,
13059 LEE JACKSON MEMORIAL HWY
FAIRFAX, VA 22033

E-401

ELECTRICAL DETAILS, DIAGRAMS

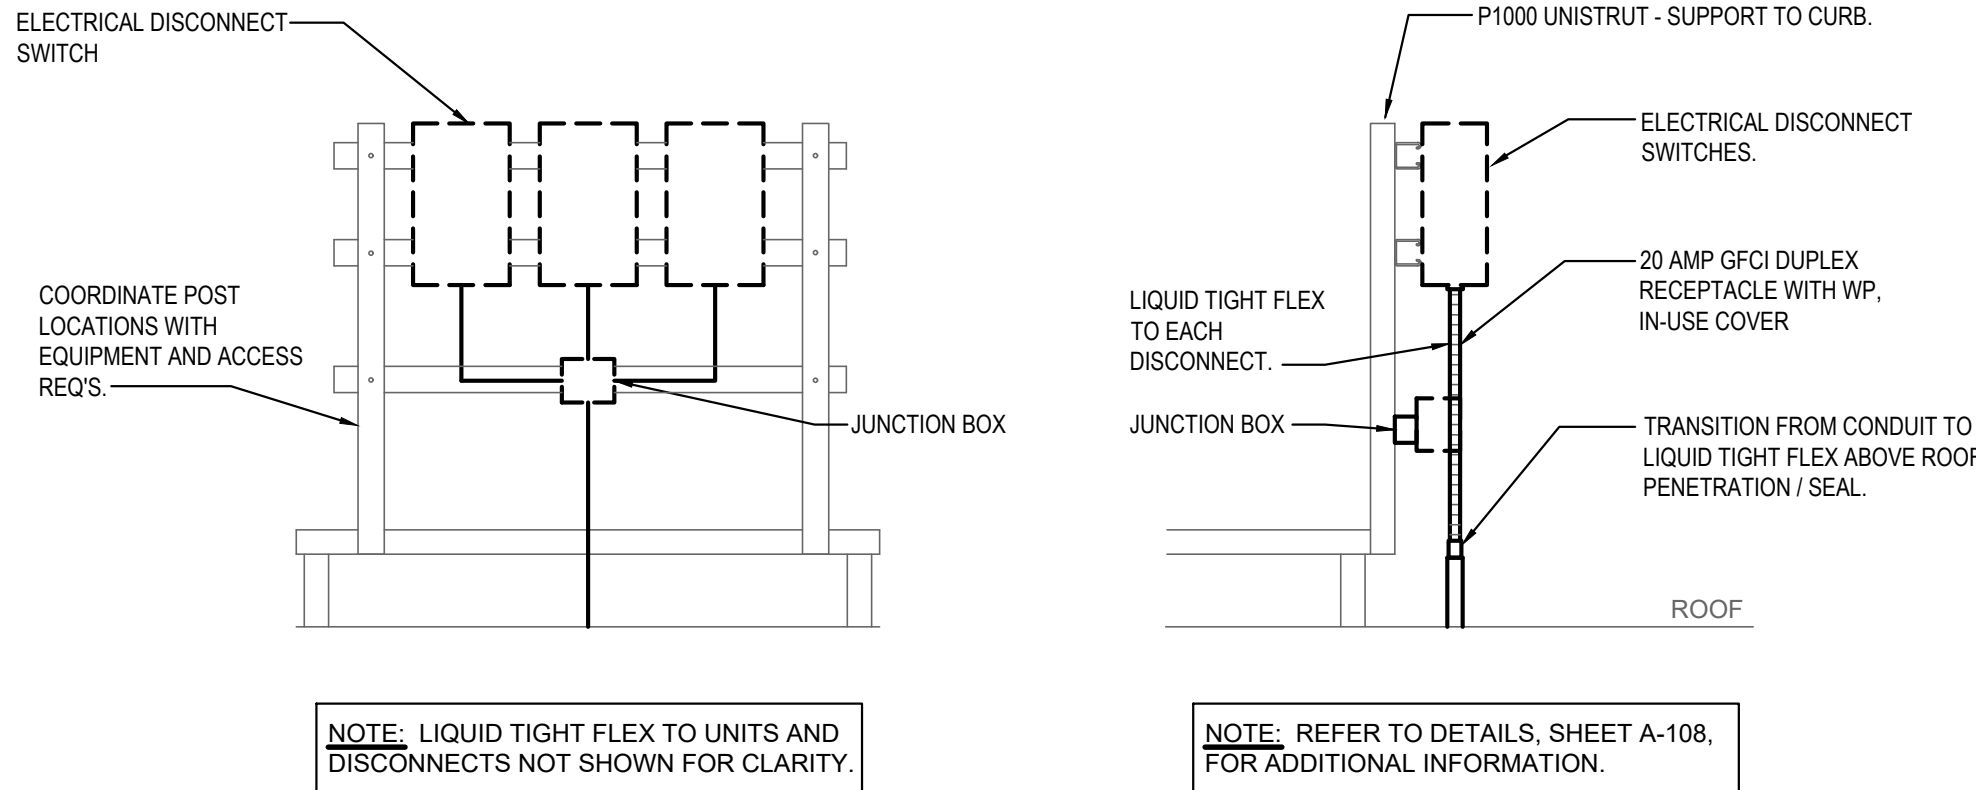

EQUIPMENT DISCONNECT SWITCH SUPPORT 2
NOT TO SCALE E-401

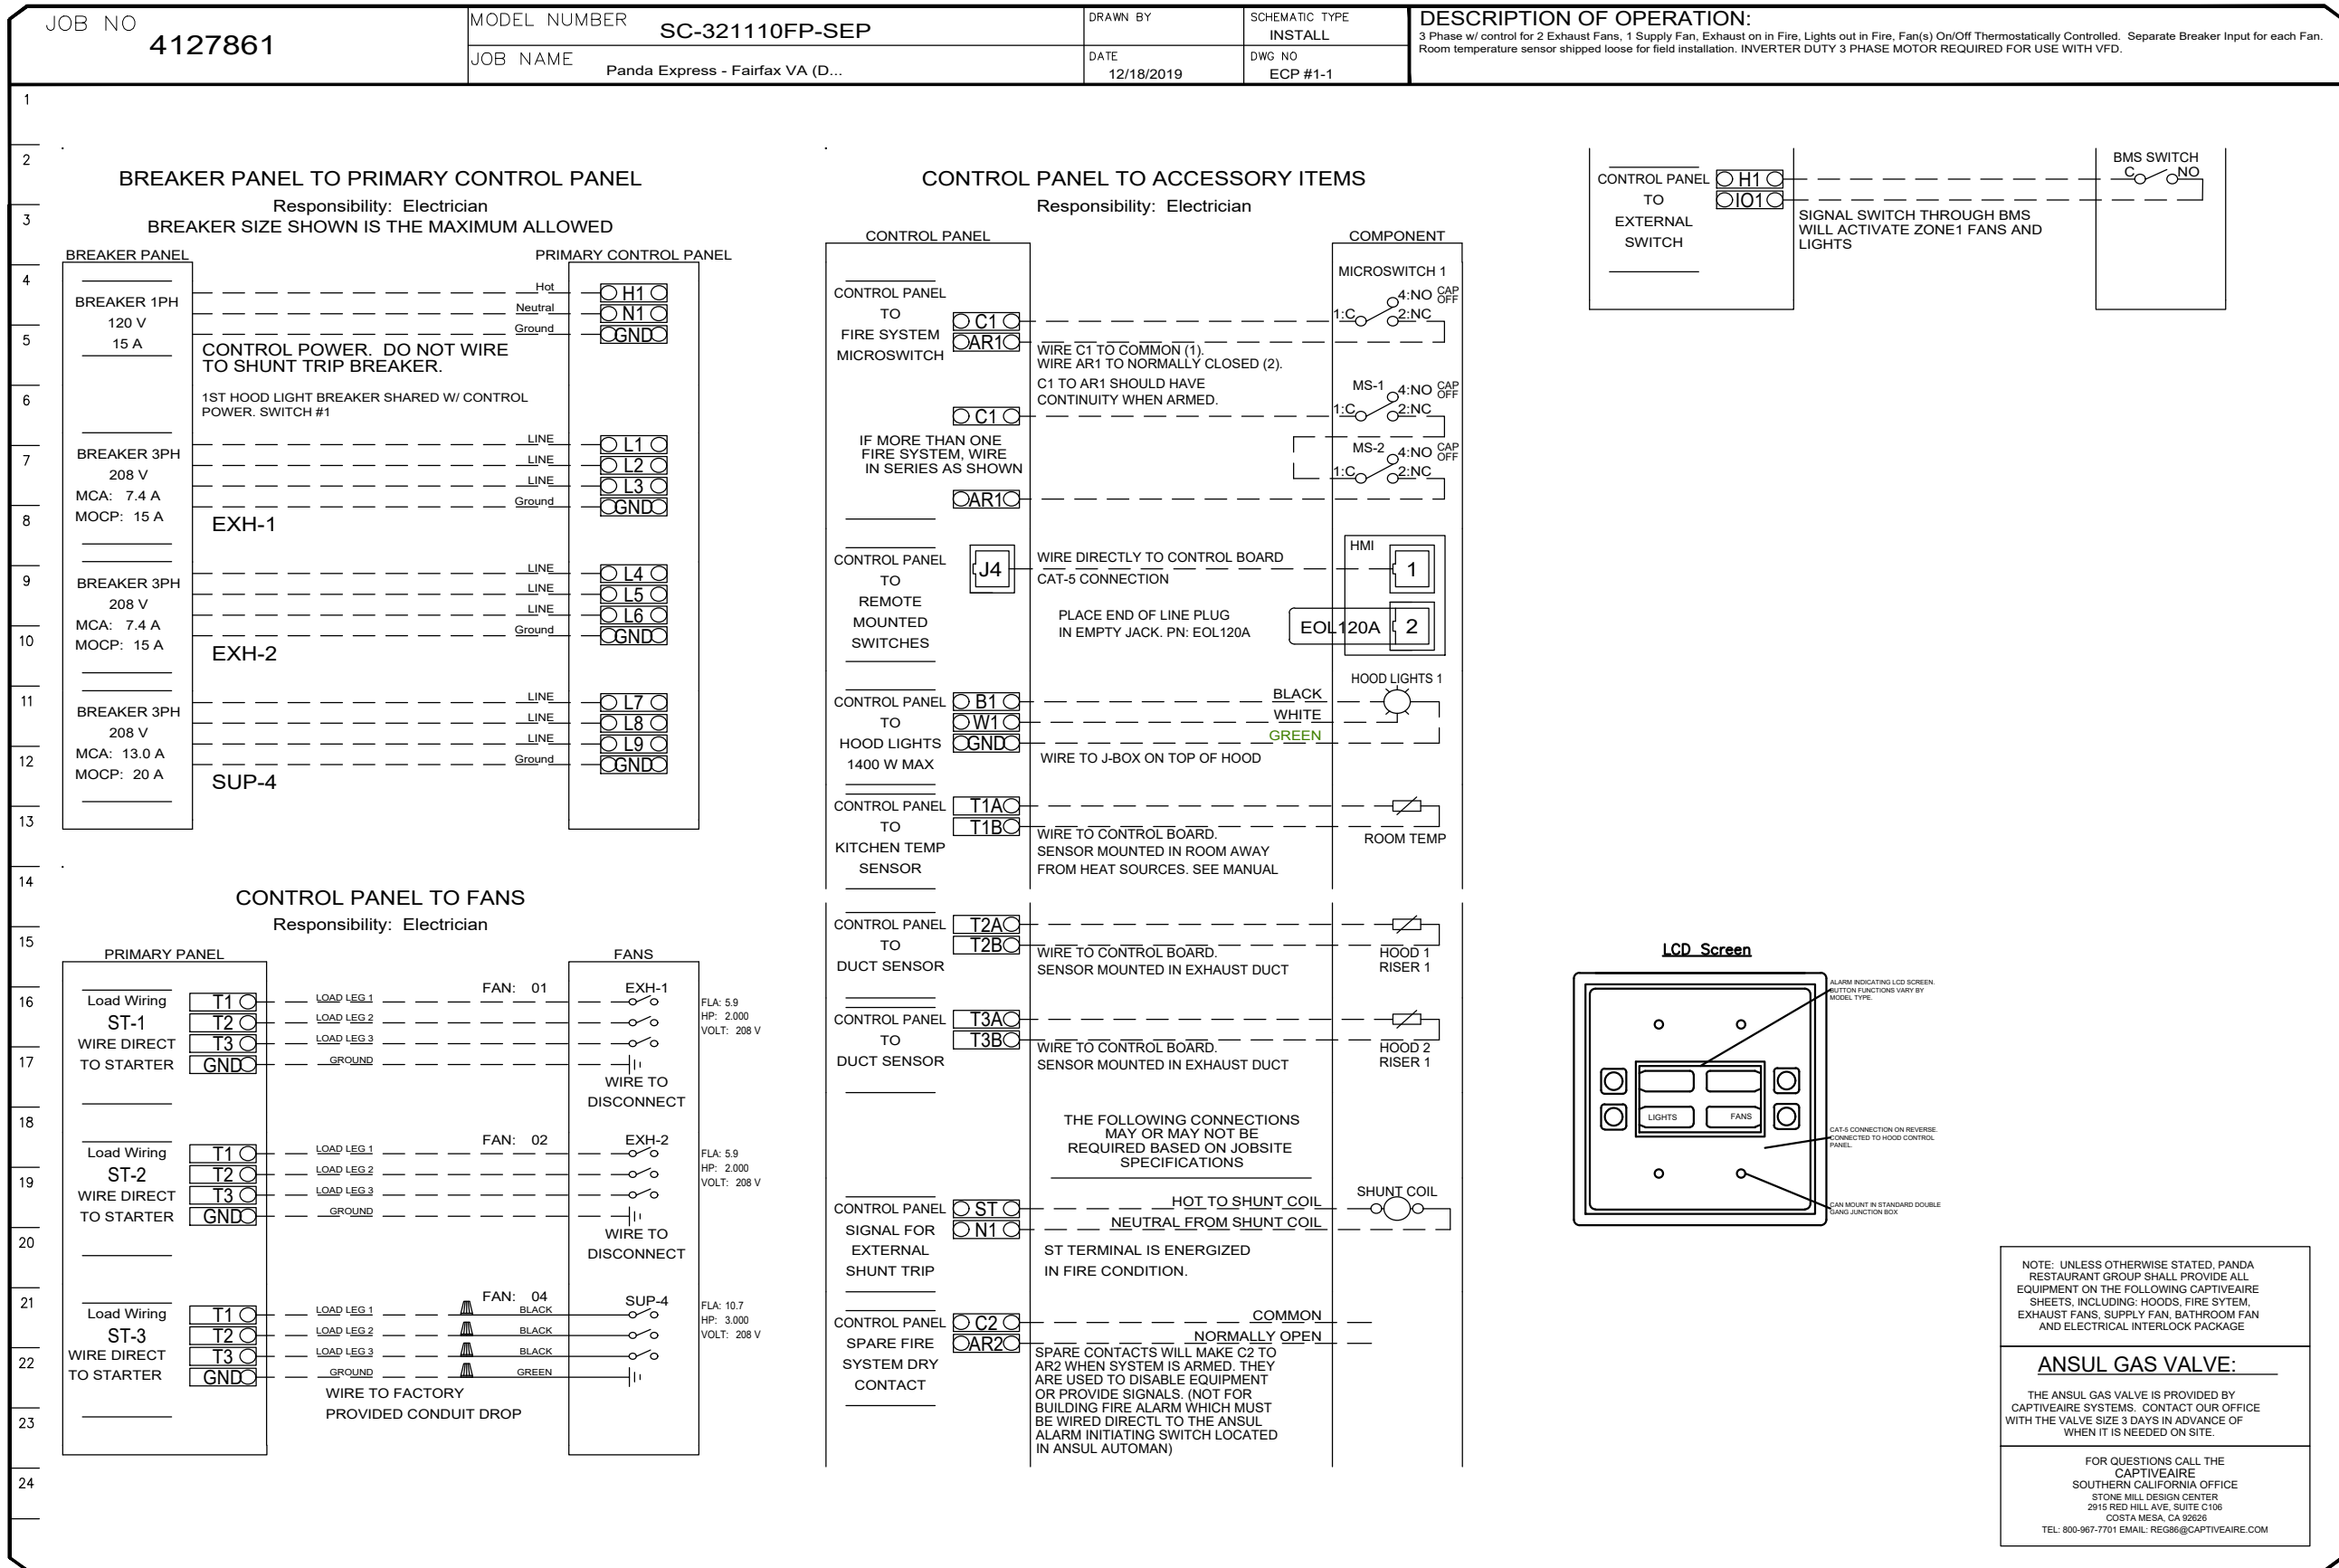

KITCHEN EXHAUST SYSTEM DIAGRAM 3
NOT TO SCALE E-401

(NOT USED) MENU BOARD & SENSOR LOOP 1
NOT TO SCALE E-401